


ALL BEDS ARE SHOWN AS
QUEEN SIZE UNLESS
OTHERWISE NOTED.

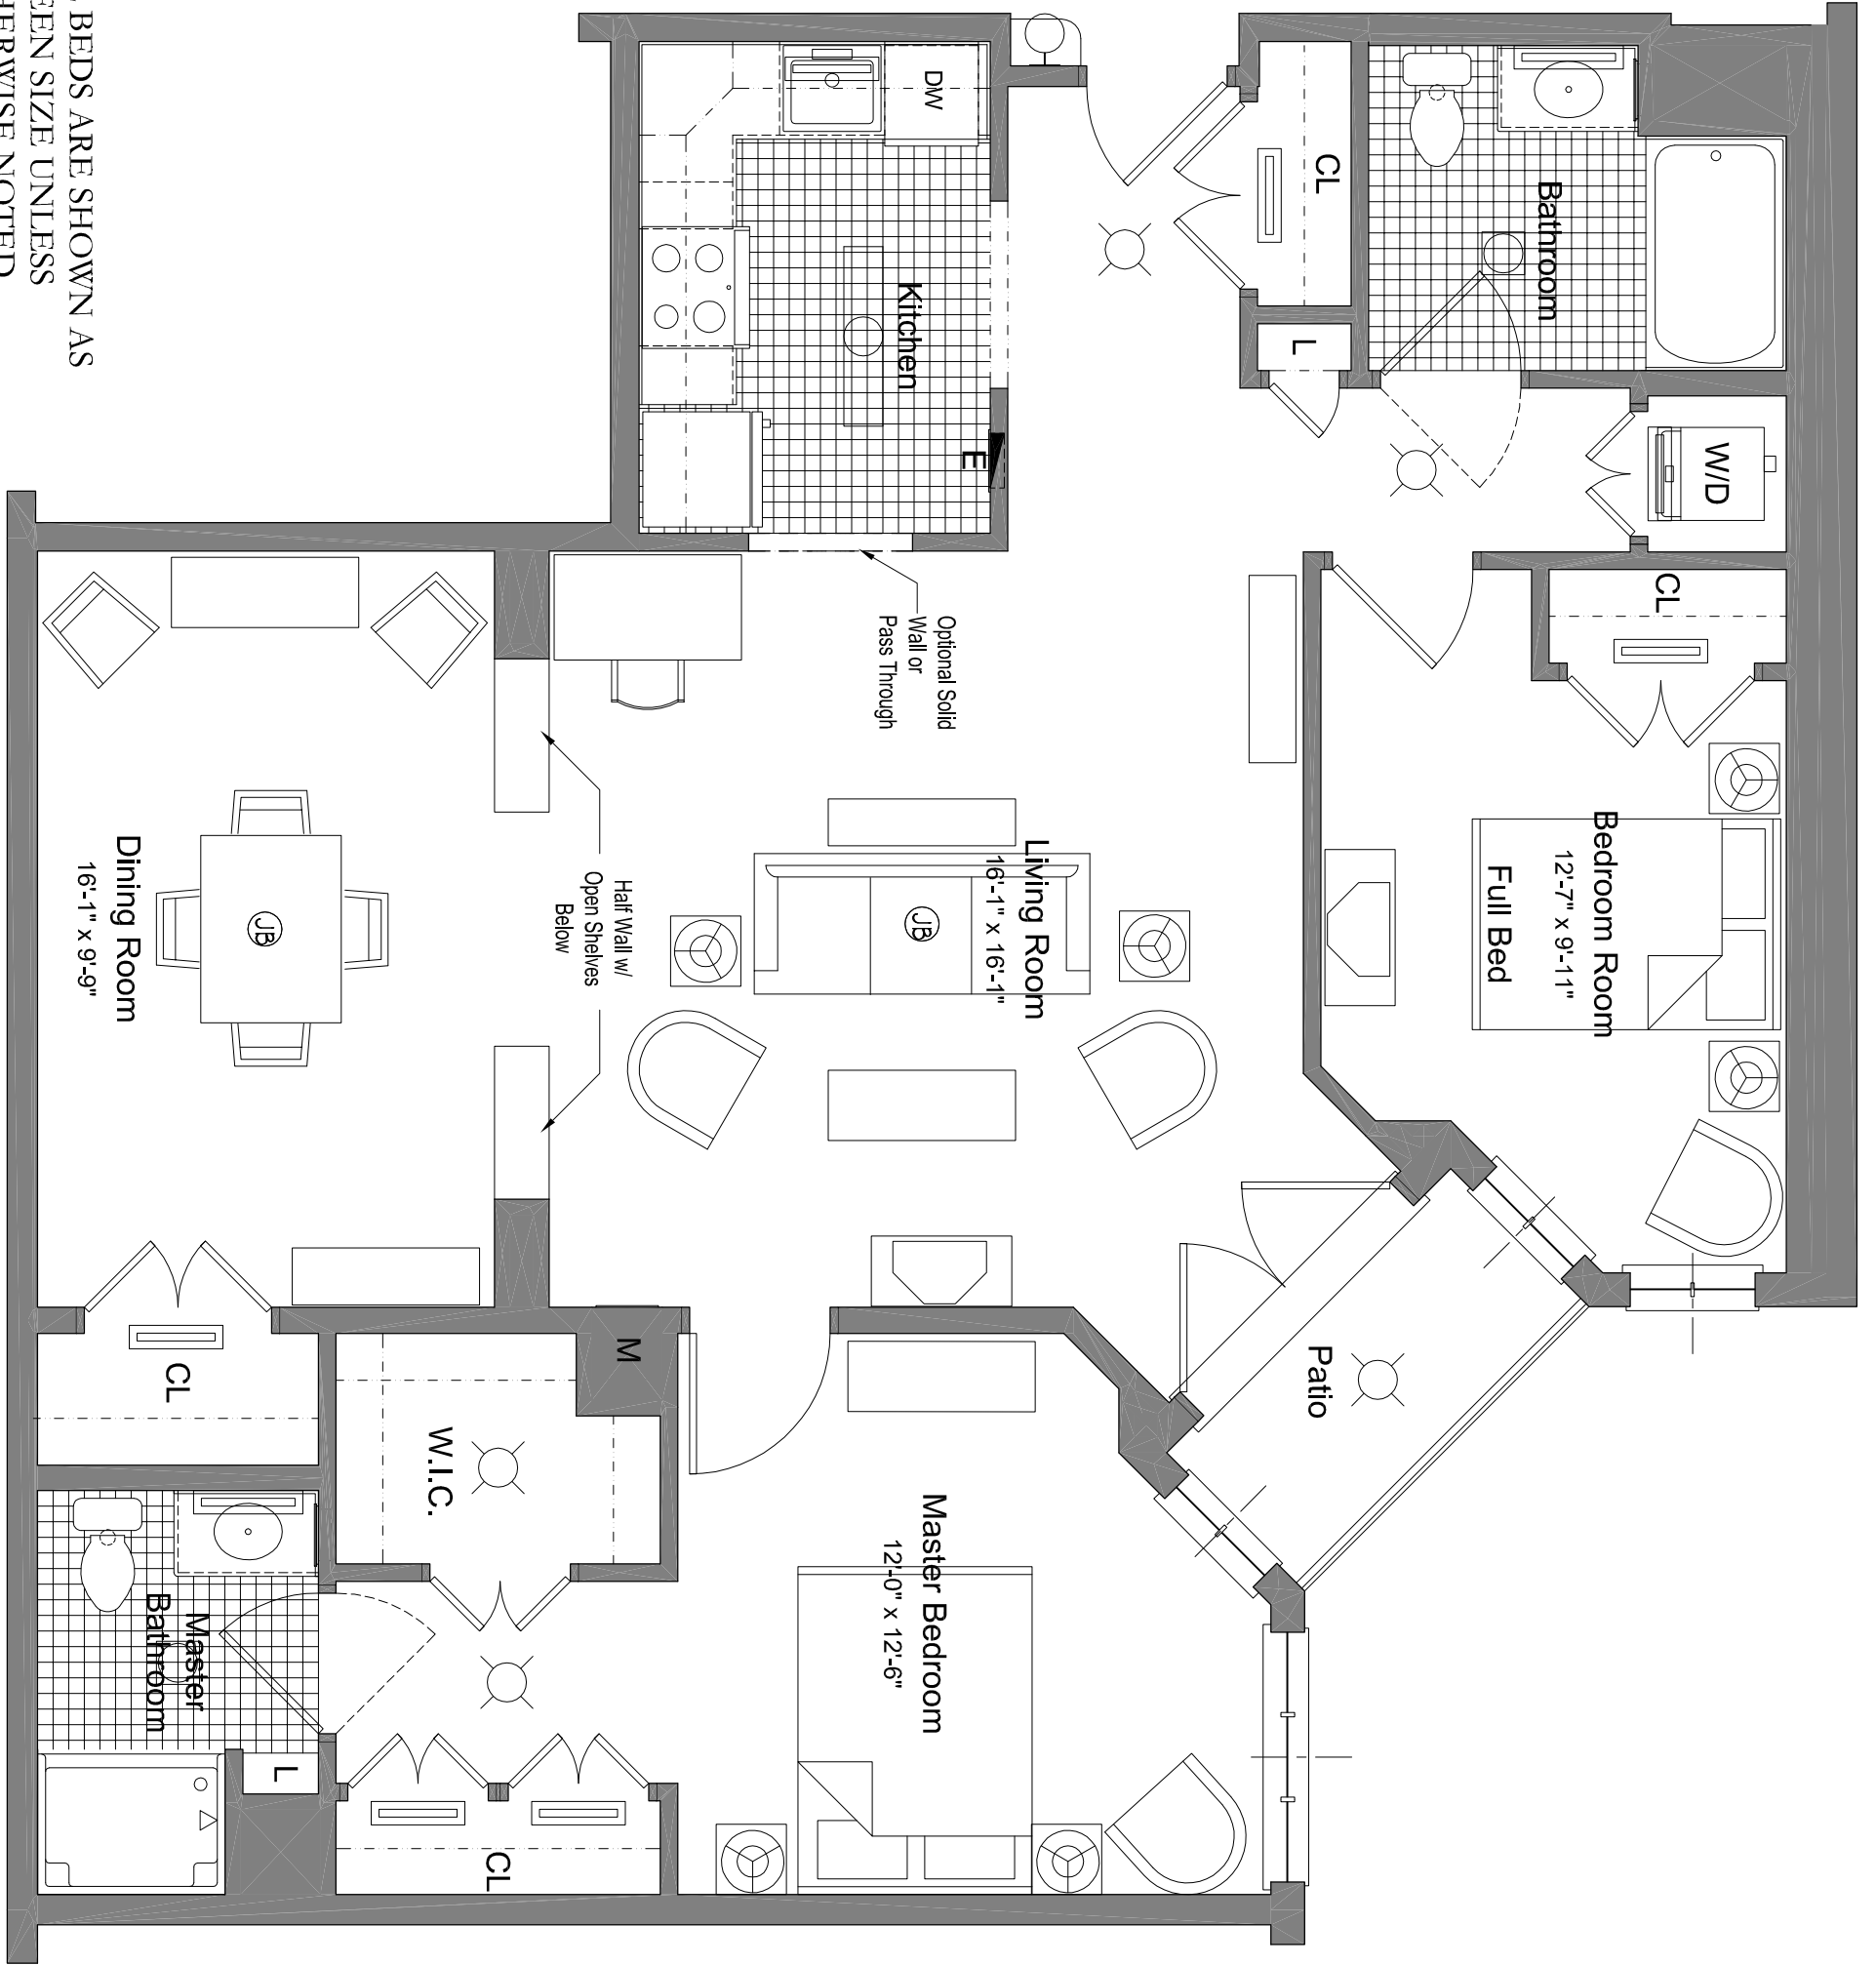

Brooks - Two Bedroom



Scale: 1/4" = 1'-0"

1,020 SQ. FT.
Unit Number: 224, 324, 424

Actual unit S.F and configuration may differ due to structural and/or mechanical layout changes during construction.